

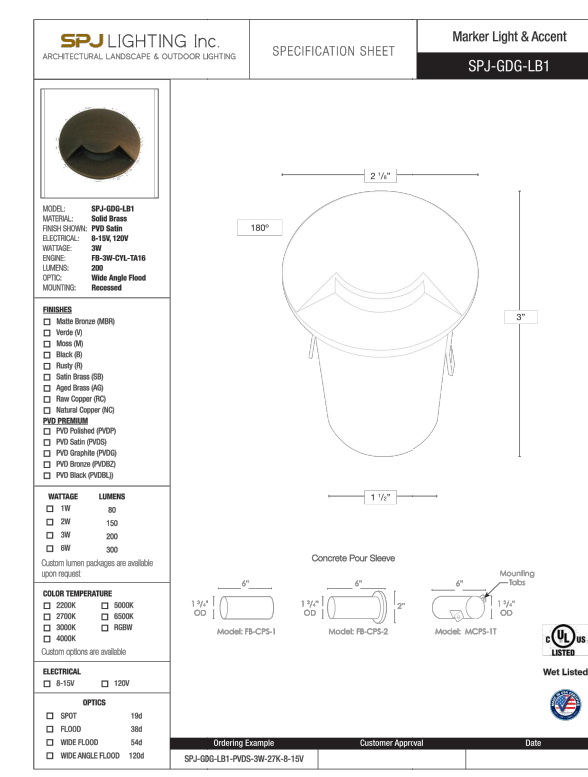



RECESSED WALL LIGHT

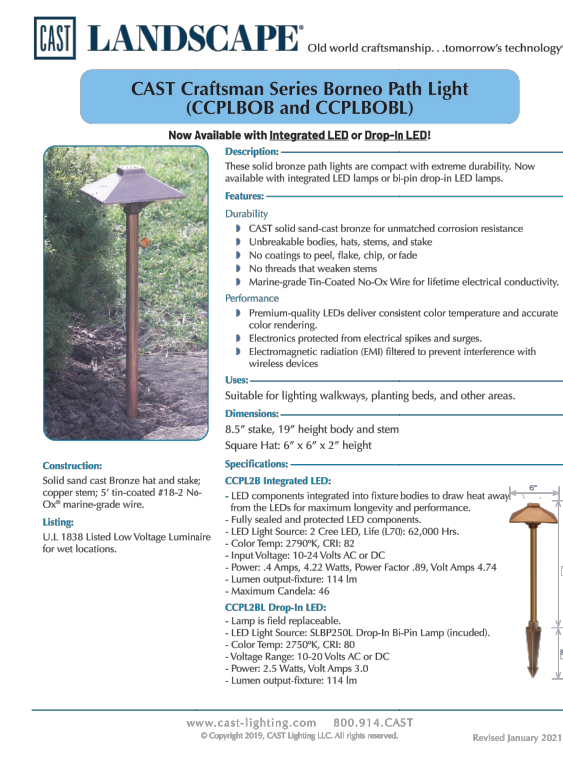

POOL LOUNGE AREA MARKER LIGHTS

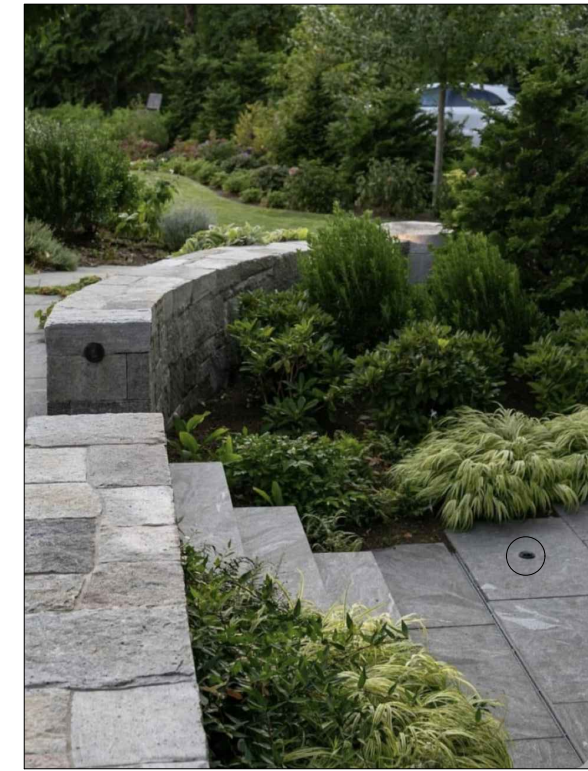


PATH LIGHT OPTIONS

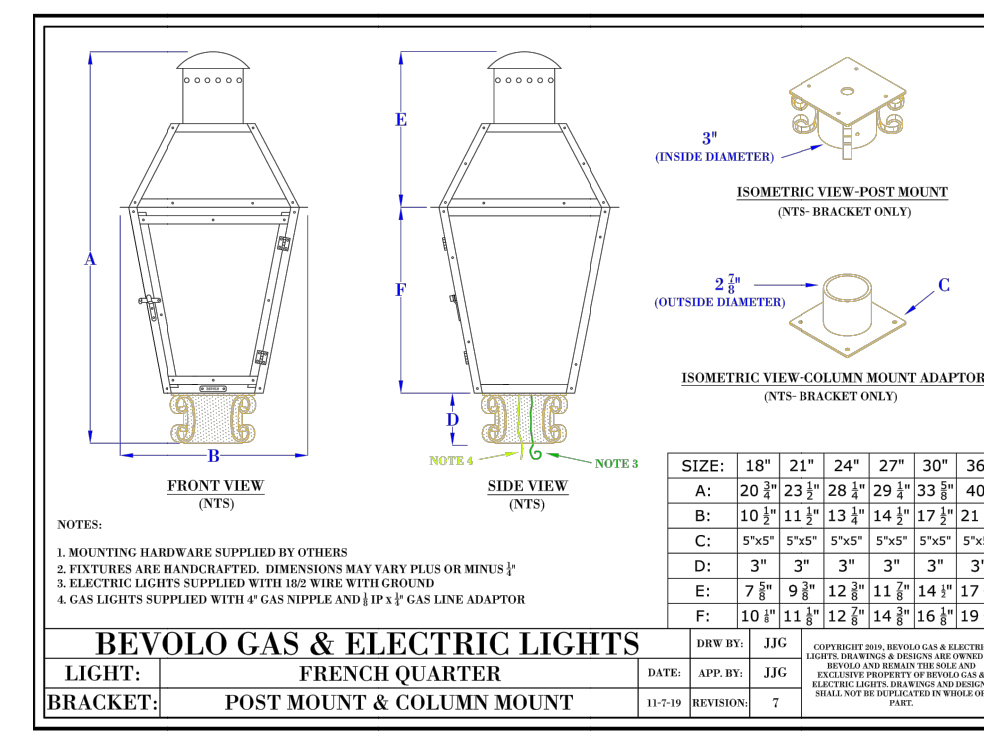


BEVOLO PIER LIGHTS



PERGOLA DOWN LIGHT
2700 Kelvin dimmable LED to be used

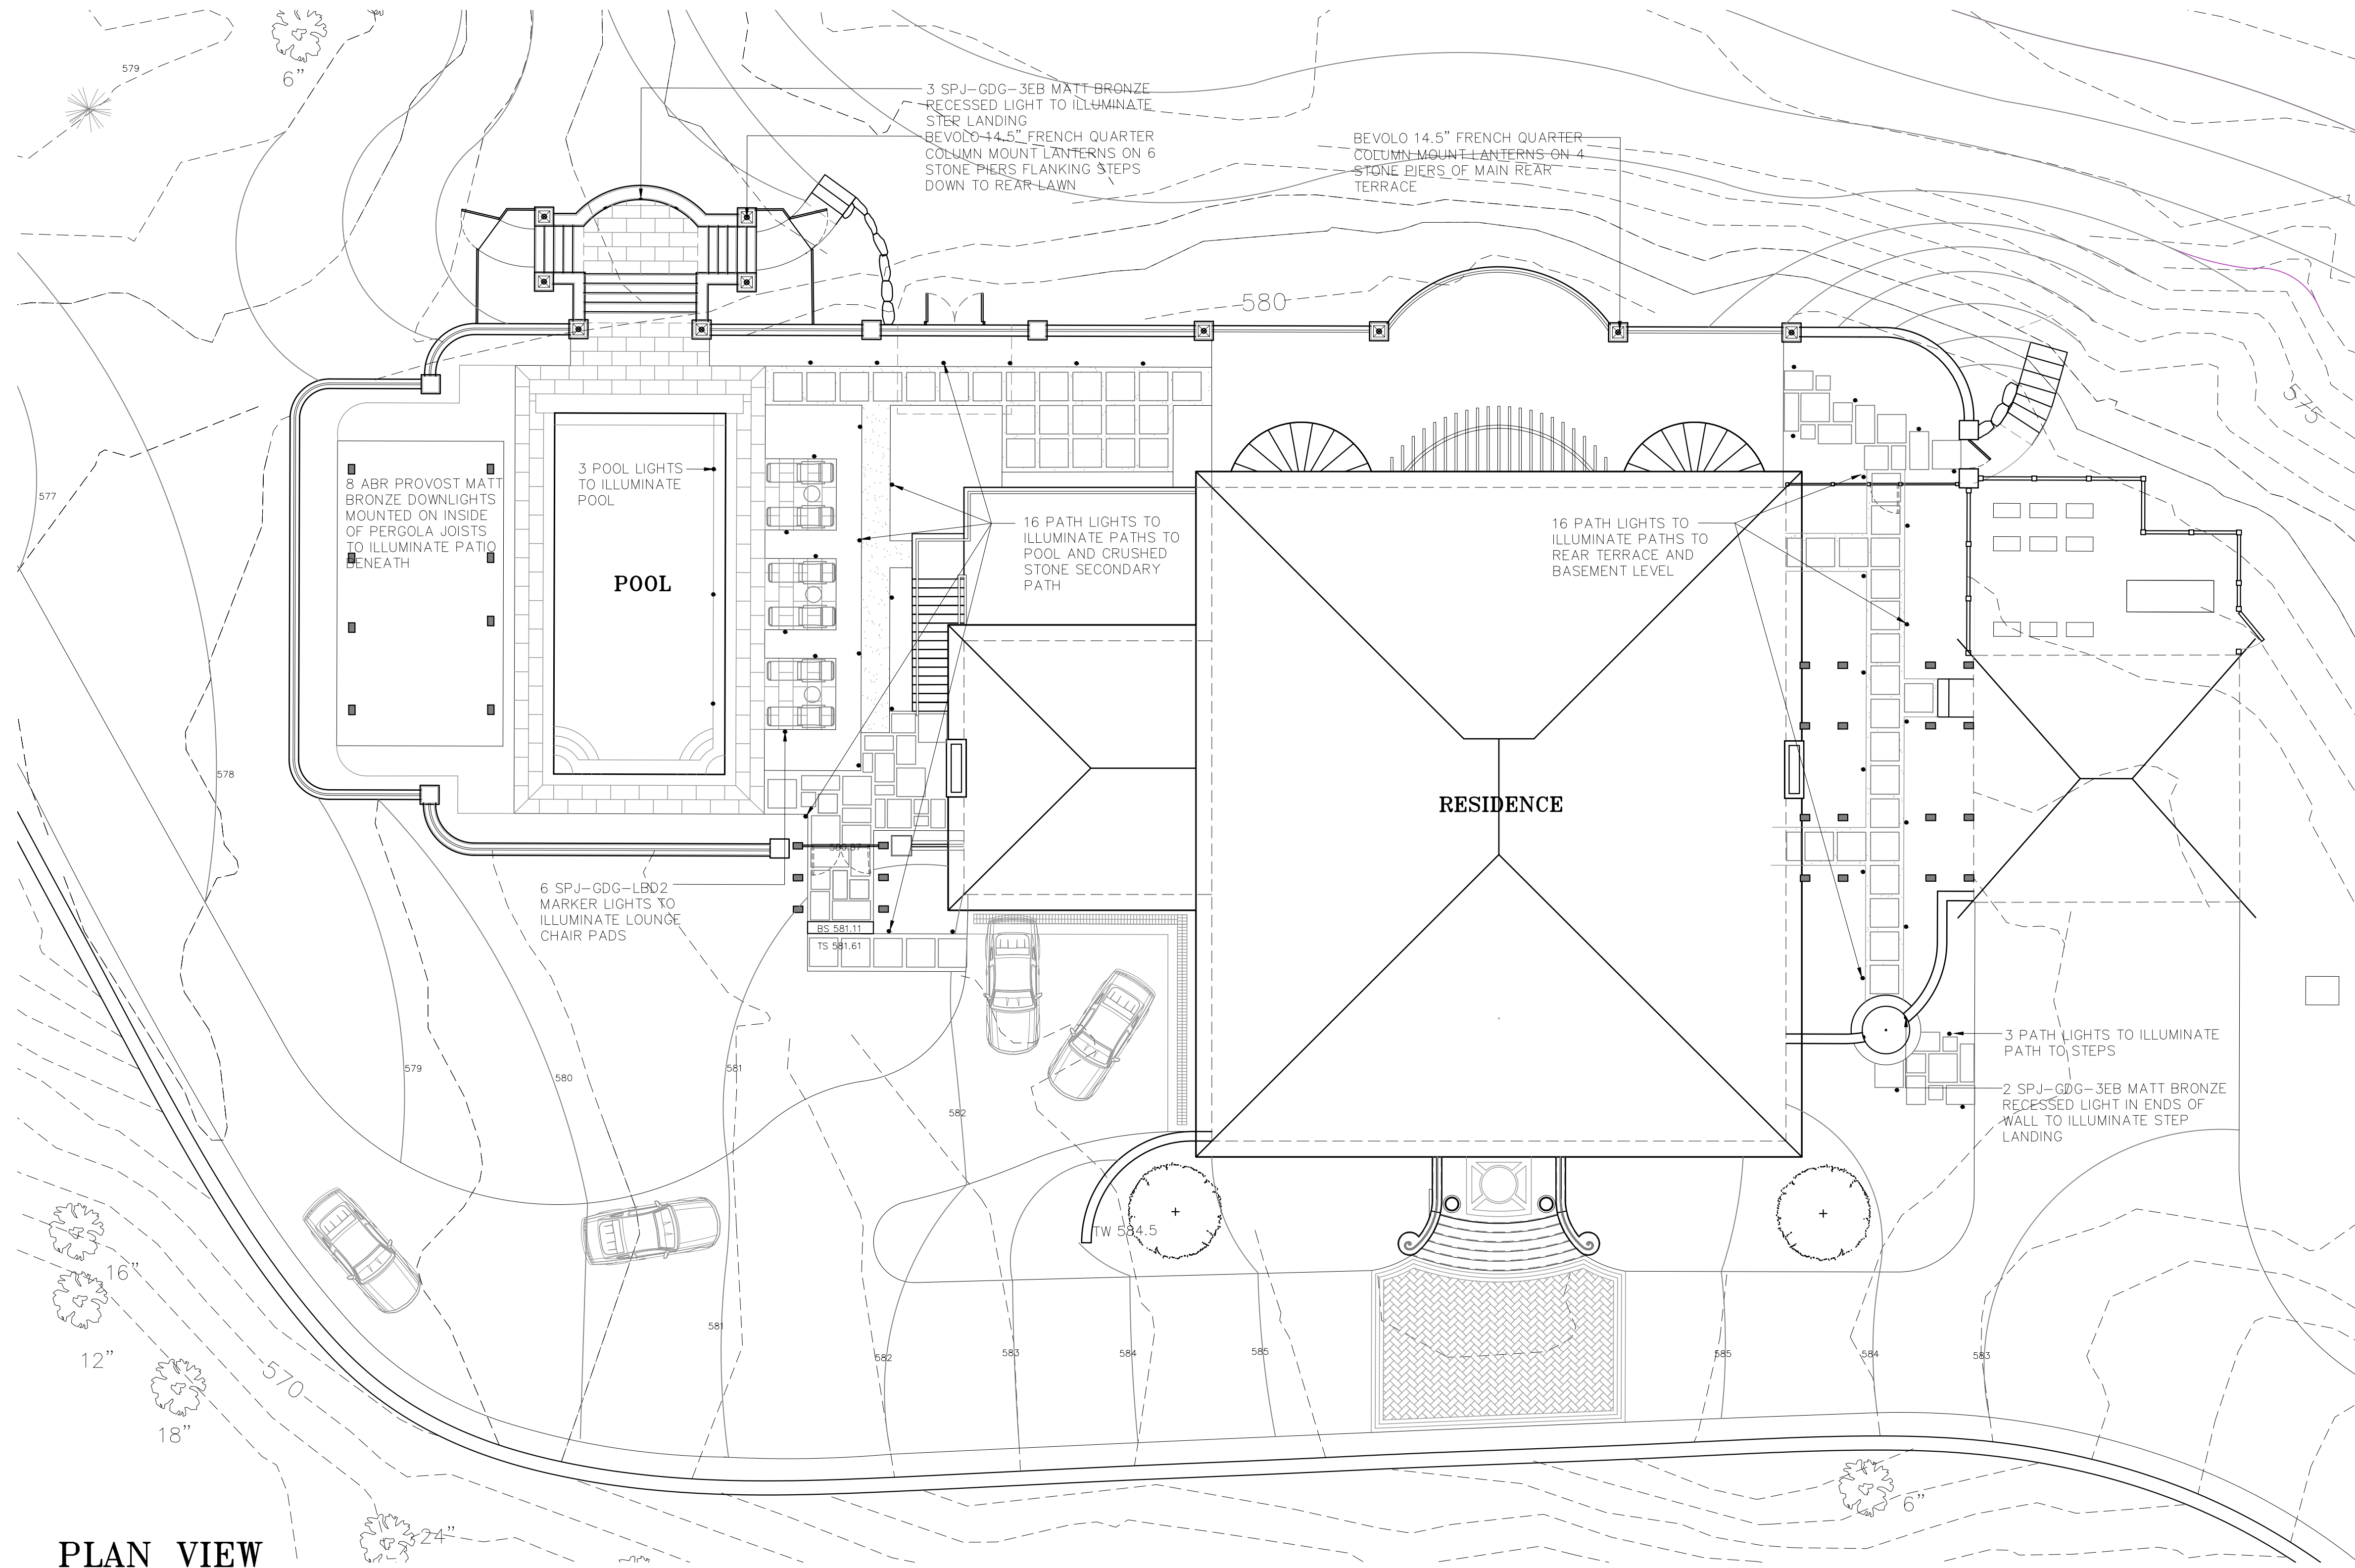

PLAN VIEW

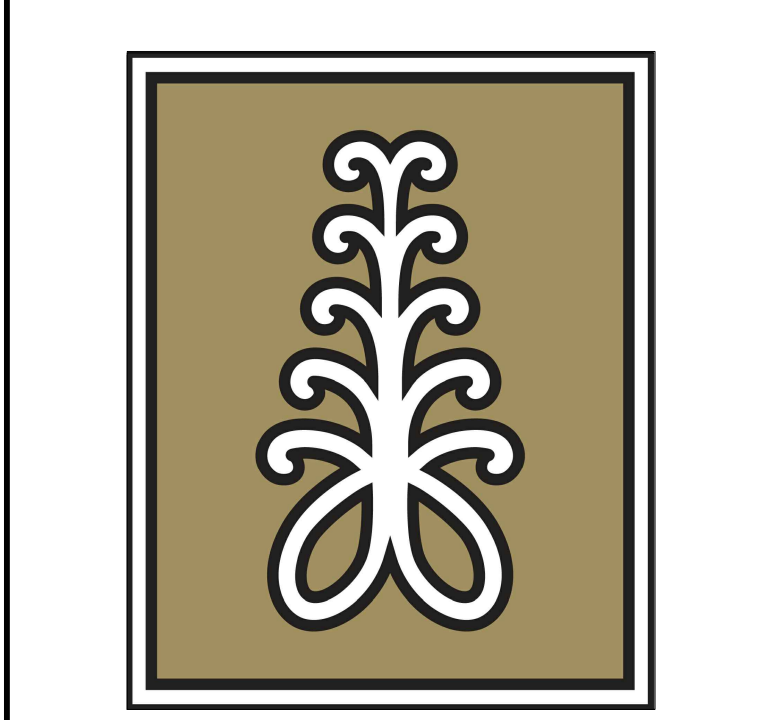

Andrea Buckingham
Licensed Landscape Architect
NJ LIC# 21AS000649
NY LIC# 002766-1

87 North Pocono Road
Mountain Lakes, NJ 07046
Tel: 973-983-0616

Email: abuckingham1a@gmail.com

SUNG SCHMIDTBERGER RESIDENCE


36 EAST LAKE ROAD
TUXEDO PARK, NY 10987

LANDSCAPE LIGHTING PLAN

Date 2/23/2024

Revisions

Drawn by APB

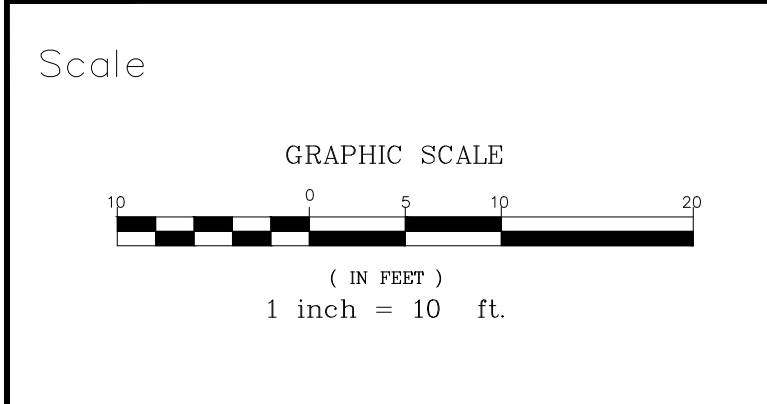

North

Sheet:
L-3